
 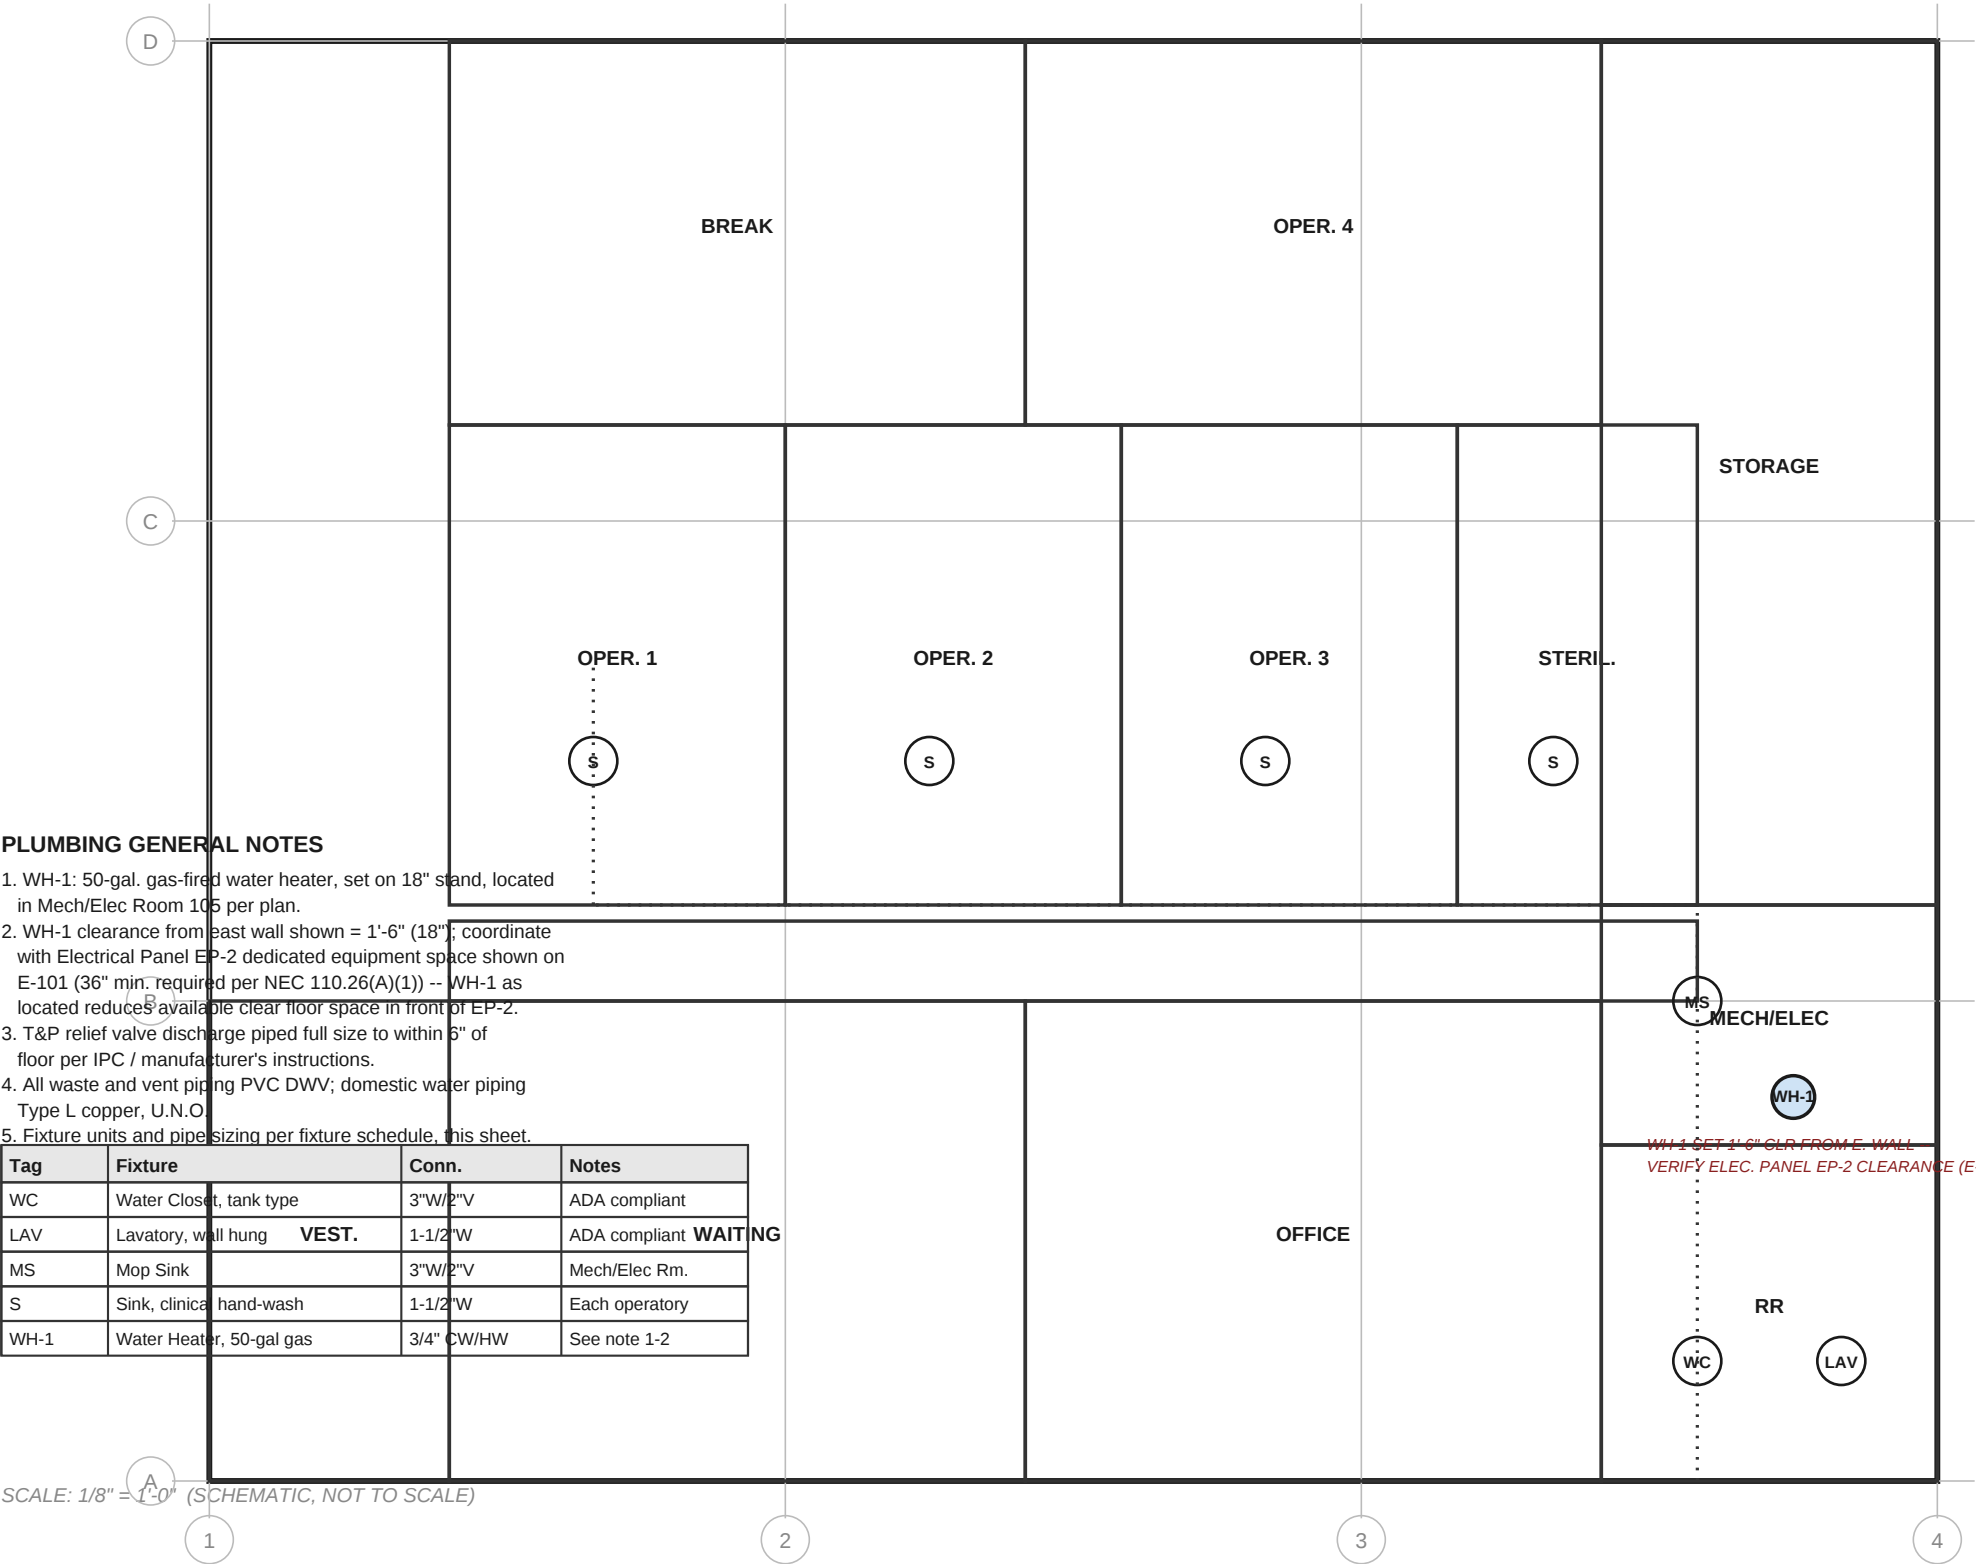


P-101 — PLUMBING PLAN

Brightline MEP Consultants — Fixtures, Water Heater & Waste Piping



SCALE: 1/8" = 1'-0" (SCHEMATIC, NOT TO SCALE)

Brightline MEP Consultants — Plumb
License No. PE-2025-0634

Riverbend Family Dental Clinic — Tenant
4400 W. Diversey Ave., Suite 100, Chicago, IL 60639
City of Chicago — Department of Buildings
Permit No. BLD2026-04471 Proj. No. 25-0138

Plumbing Plan
06/15/2025
Drawn: J.T. Checked: R.H. Date: 06/15/2025

P-101
Rev A