


M-101 — MECHANICAL (HVAC) PLAN

Brightline MEP Consultants — Ductwork, Diffusers & Rooftop Equipment

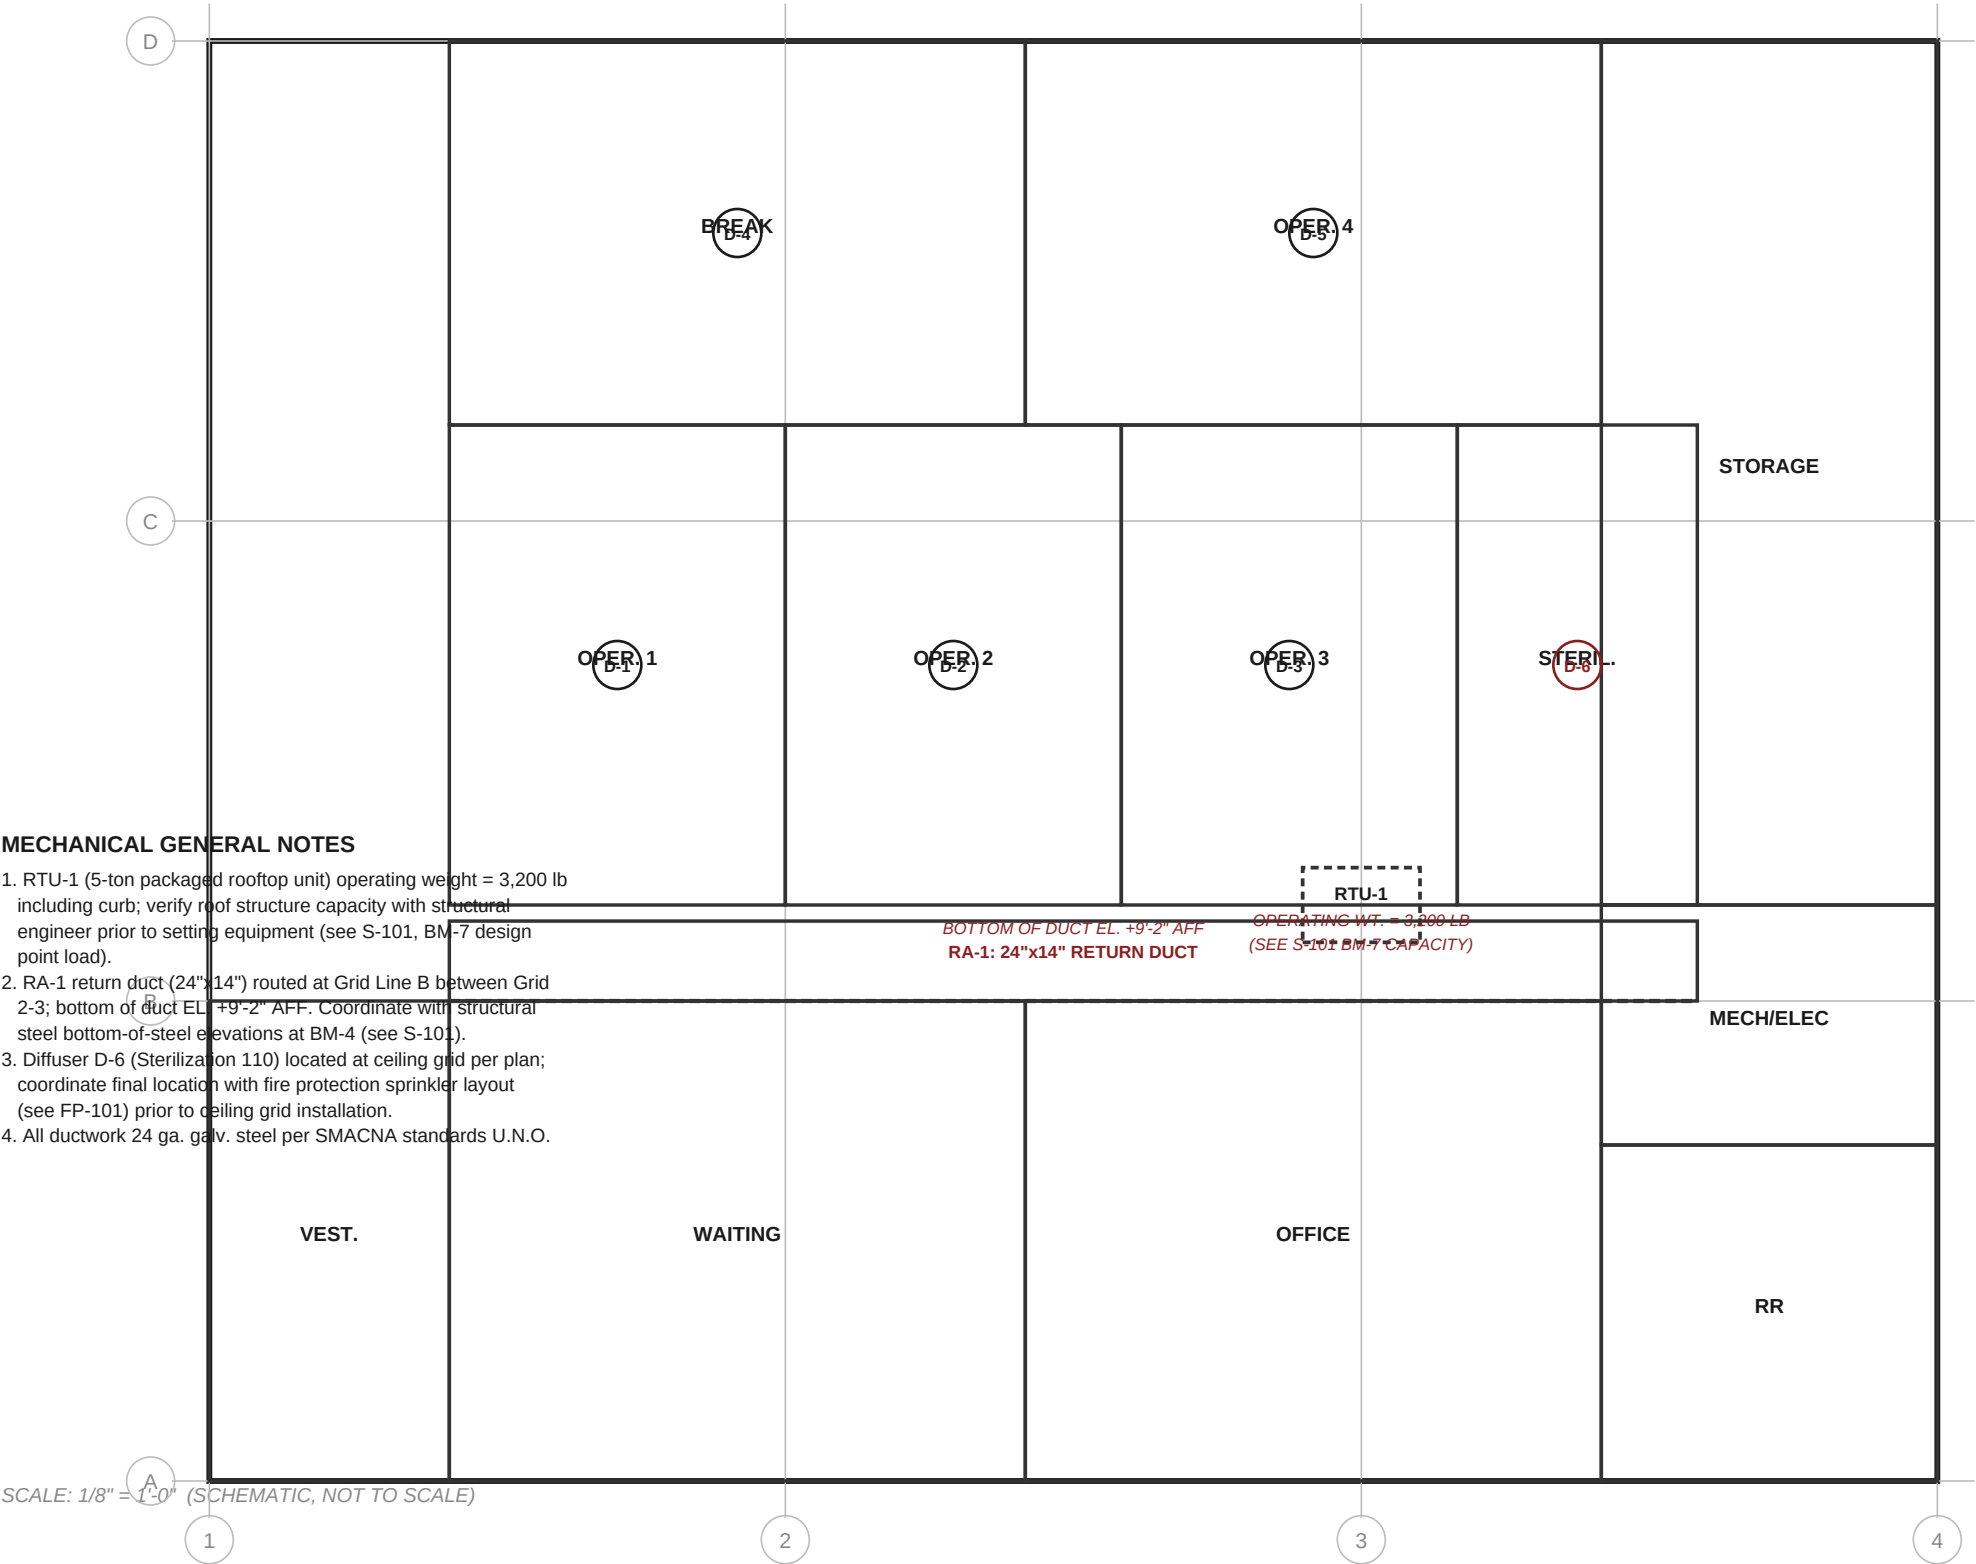

Brightline MEP Consultants — Mecha
License No. ME-2025-0632

Riverbend Family Dental Clinic — Tenant
4400 W. Diversey Ave., Suite 100, Chicago, IL 60639
City of Chicago — Department of Buildings
Permit No. BLD2026-04471 Proj. No. 25-0138

Mechanical Plan
06/15/2025 Issued for Permit
Drawn: J.T. Checked: R.H. Date: 06/15/2025

M-101
Rev A